



2008/08/08 10:00 AM  
D:\Projects\I-35\Drawings\Sheet 14.dwg  
D:\Projects\I-35\Drawings\Sheet 14.dwg  
D:\Projects\I-35\Drawings\Sheet 14.dwg

MATCHLINE IH35E STA 775+00

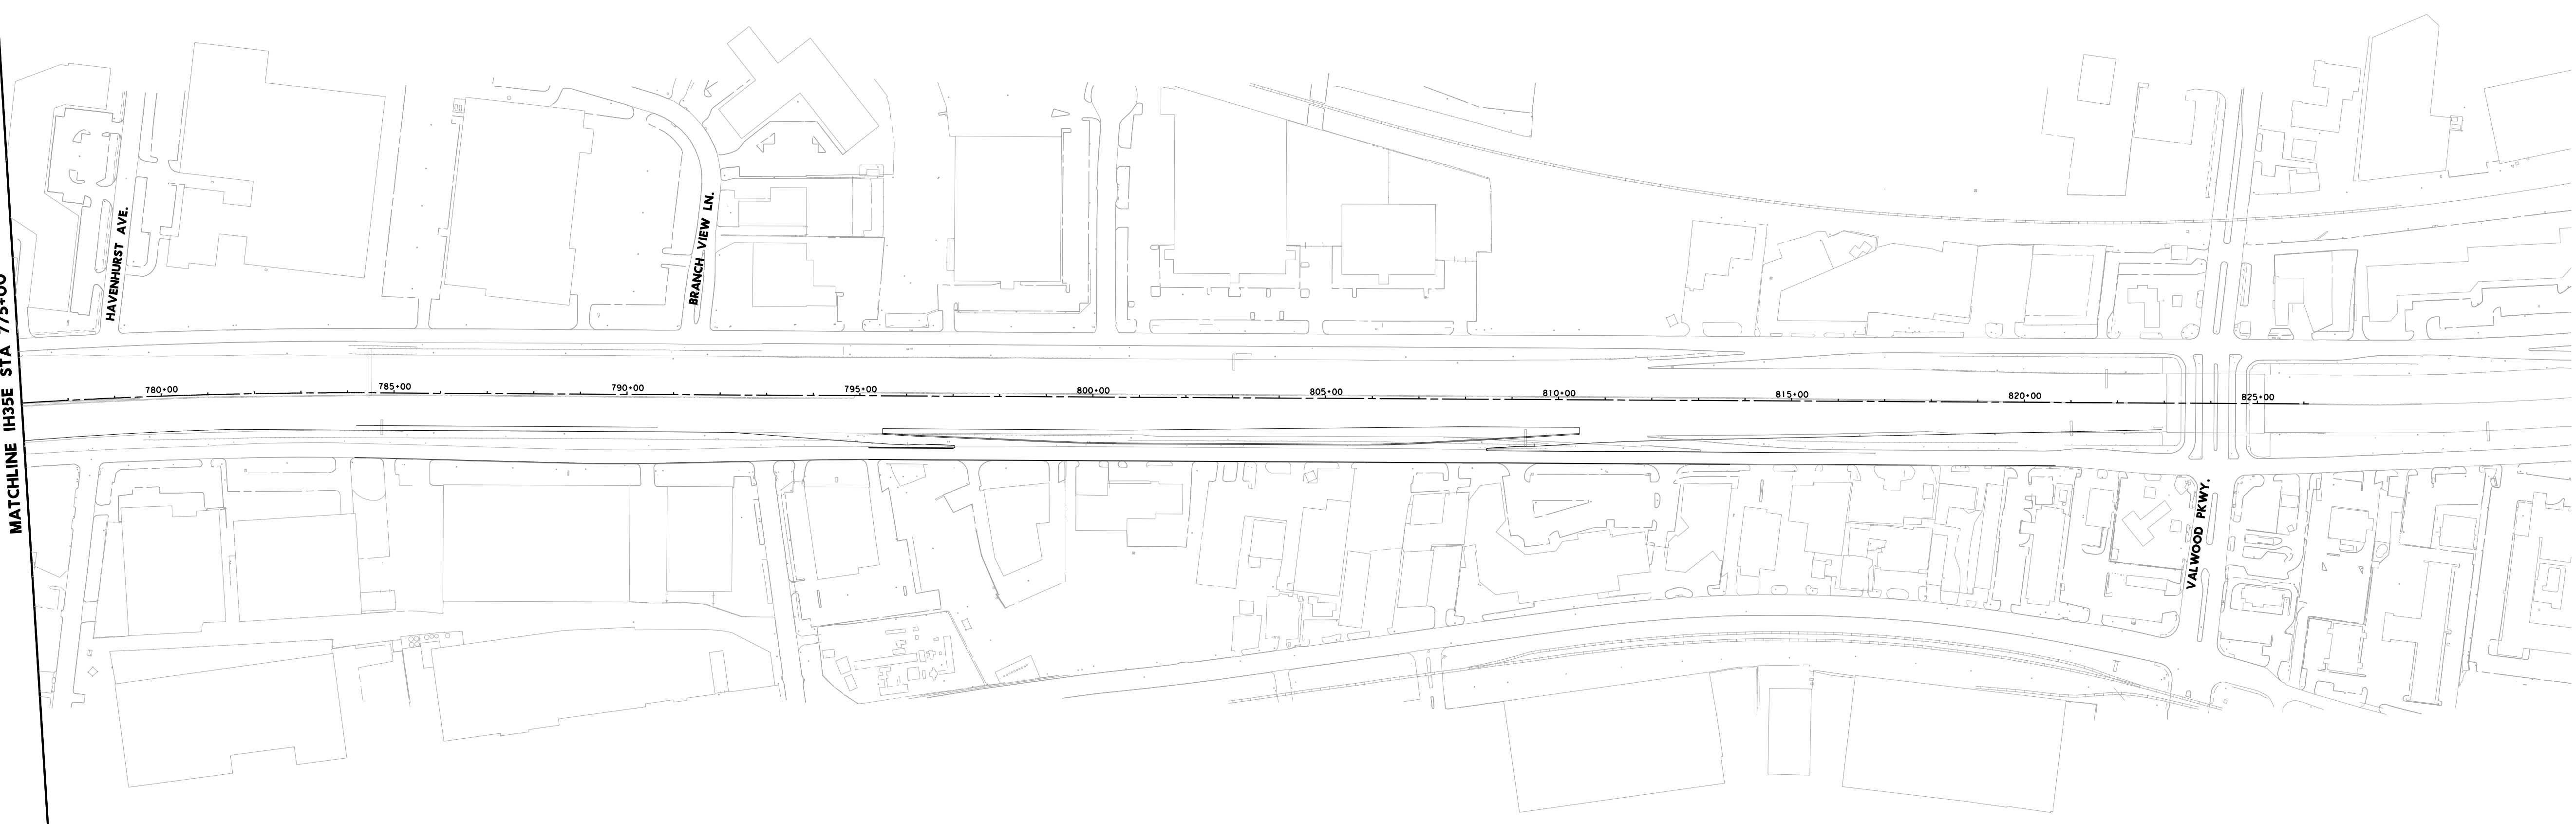

LEGEND	
	EXISTING DRAINAGE STRUCTURE
	PROPOSED DRAINAGE STRUCTURE
	EXISTING ROW
	PROPOSED ROW
	* PROPOSED WET/DETENTION PONDS
LINK SIZES NOTED ONLY WHEN CHANGES OCCUR	

 THE CONTRACTOR SHALL OBTAIN TEMPORARY CONSTRUCTION EASEMENTS AS NEEDED TO CONSTRUCT HEADWALLS, RIPRAP AND MISCELLANEOUS CONSTRUCTION ITEMS ADJACENT TO THE PROPOSED ROW.



I.H. 35	
DRAINAGE LAYOUT	
SHEET 14 OF 14	Page 101

DATE	05/08/2008		DRAGADOS USA	DMJM HARRIS	AECOM
SHEET No.	D14				