


LEGEND

- EXISTING DRAINAGE STRUCTURE
- PROPOSED DRAINAGE STRUCTURE
- EXISTING ROW
- PROPOSED ROW
- * PROPOSED WET/DETENTION PONDS
- LINK SIZES NOTED ONLY WHEN CHANGES OCCUR

THE CONTRACTOR SHALL OBTAIN TEMPORARY CONSTRUCTION EASEMENTS AS NEEDED TO CONSTRUCT HEADWALLS, RIPRAP AND MISCELLANEOUS CONSTRUCTION ITEMS ADJACENT TO THE PROPOSED ROW.

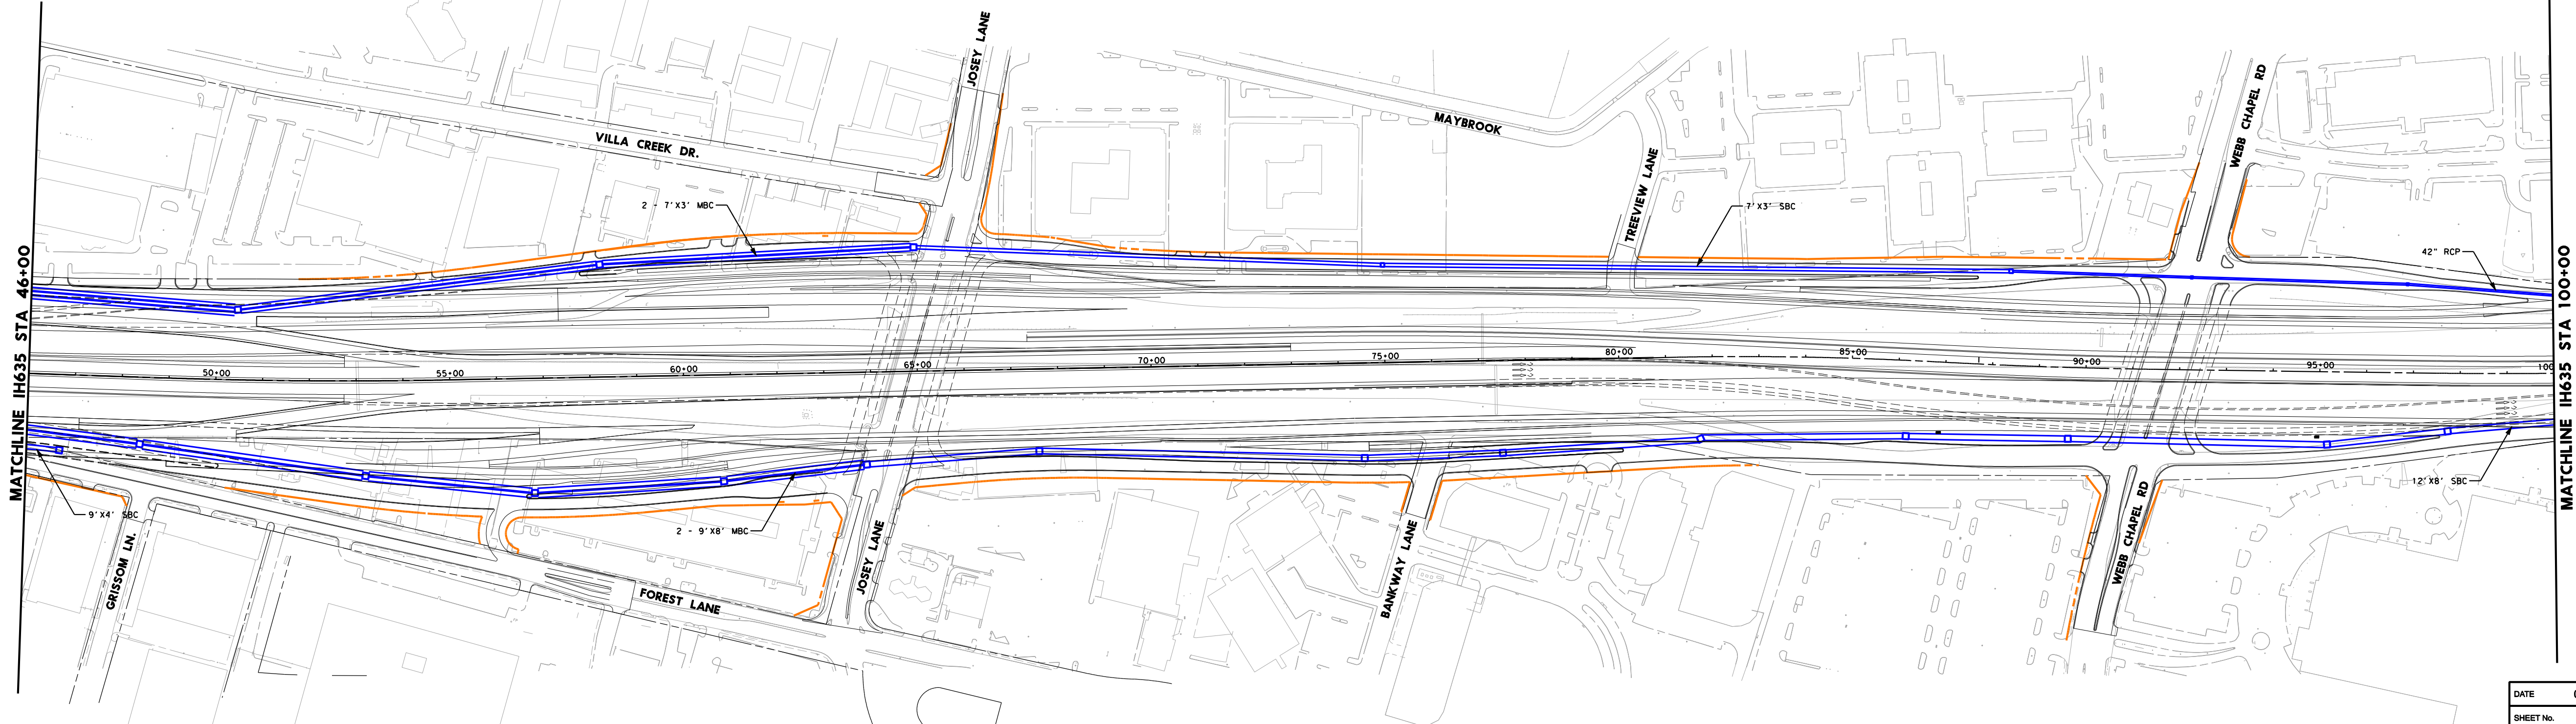

I.H. 635	
DRAINAGE LAYOUT	
SHEET 2 OF 14	Page 89

DATE 05/08/2008
SHEET No. D2

21/08/2008 11:03:00 AM C:\Projects\I635\Drawings\I635-14.dwg
2008/08/08 11:03:00 AM
2008/08/08 11:03:00 AM
2008/08/08 11:03:00 AM
2008/08/08 11:03:00 AM